


Calculation Summary									
Description	Avg	Max	Min	Min/Avg	Min/Max	Units	PtSpcLr	PtSpcTb	# Pts
Playing Area 24m x 11m	512.93	614	378	0.74	0.62	Lux	3	2.75	45
Total Area 36m x 18m	458.22	619	293	0.64	0.47	Lux	2.2	2	144

Luminaire Schedule							Filename
Symbol	Qty	Label	Lum. Lumens	MF	Description		
	8	SL6-4A	57384	0.900	Sportslite 6, 400w LED 5000K Optic A Asymmetric Wide Beam		5SBS00401-A.ies

Luminaire Location Summary						
LumNo	Label	X	Y	Z	Orient	Tilt
1	SL6-4A	-10	9	8	225	0
2	SL6-4A	-9.5	9	8	310	0
3	SL6-4A	9.5	9	8	230	0
4	SL6-4A	10	9	8	315	0
5	SL6-4A	-10	-9	8	135	0
6	SL6-4A	-9.5	-9	8	50	0
7	SL6-4A	9.5	-9	8	130	0
8	SL6-4A	10	-9	8	45	0
Total Quantity: 8						

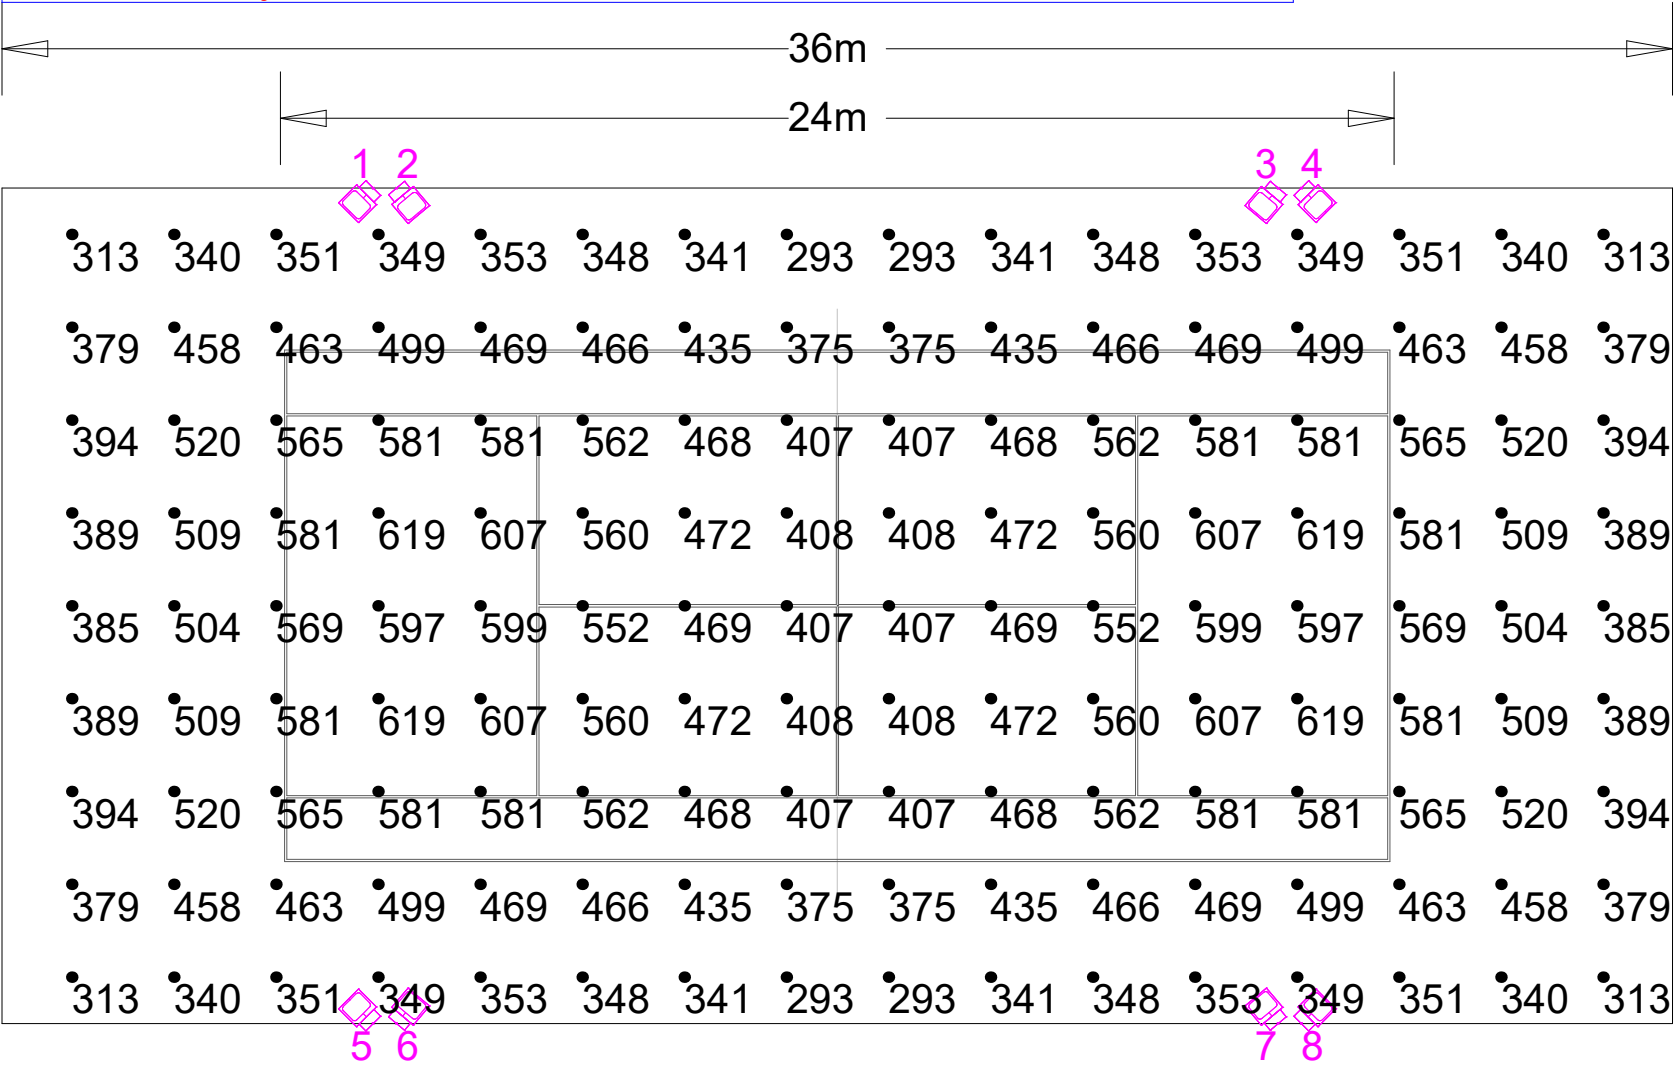

NOTE:
Actual results achieved may vary from predicted values due to normal deviation in luminaire installation, electrical supply, equipment tolerances, obstructions including poles, brackets and mounting arms, reflectances etc.
This design is for general guidance only & its use is subject to conditions (available on request).

Based On
Lumen Output at 20000 Hours,
Spot Lamp Replacement,
Normal Environment,
Annual Cleaning,
Ground is Level.

VeeLite		
Project: Standard Tennis Court Class 1 500 Lux 0.7 Uniformity		
Client: Veelite		
Project No: VL-STC	Drawing No: VL-STC-CL1	Drawn By: GK
Date: 27/09/2023	Scale: As shown	REV NO: A
Single Tennis Court 500lux 8m.AGI		