


Calculation Summary									
Description	Avg	Max	Min	Min/Avg	Min/Max	Units	PtSpcLr	PtSpcTb	# Pts
Playing Area 24 x11m	214.67	283	161	0.75	0.57	Lux	3	2.75	45
Total Area 36x 18m	200.28	288	121	0.60	0.42	Lux	2.2	2	144

Luminaire Schedule						
Symbol	Qty	Label	Lum. Lumens	MF	Description	Filename
	8	A24	32463	0.900	AkraLED 240w LED, 4K, Asymmetric	5SF240LBA.ies

Luminaire Location Summary						
LumNo	Label	X	Y	Z	Orient	Tilt
1	A24	-9.75	9	8	231	5
2	A24	-9.25	9	8	305	5
3	A24	9.25	9	8	235	5
4	A24	9.75	9	8	309	5
5	A24	-9.75	-9	8	129	5
6	A24	-9.25	-9	8	55	5
7	A24	9.25	-9	8	125	5
8	A24	9.75	-9	8	51	5
Total Quantity: 8						

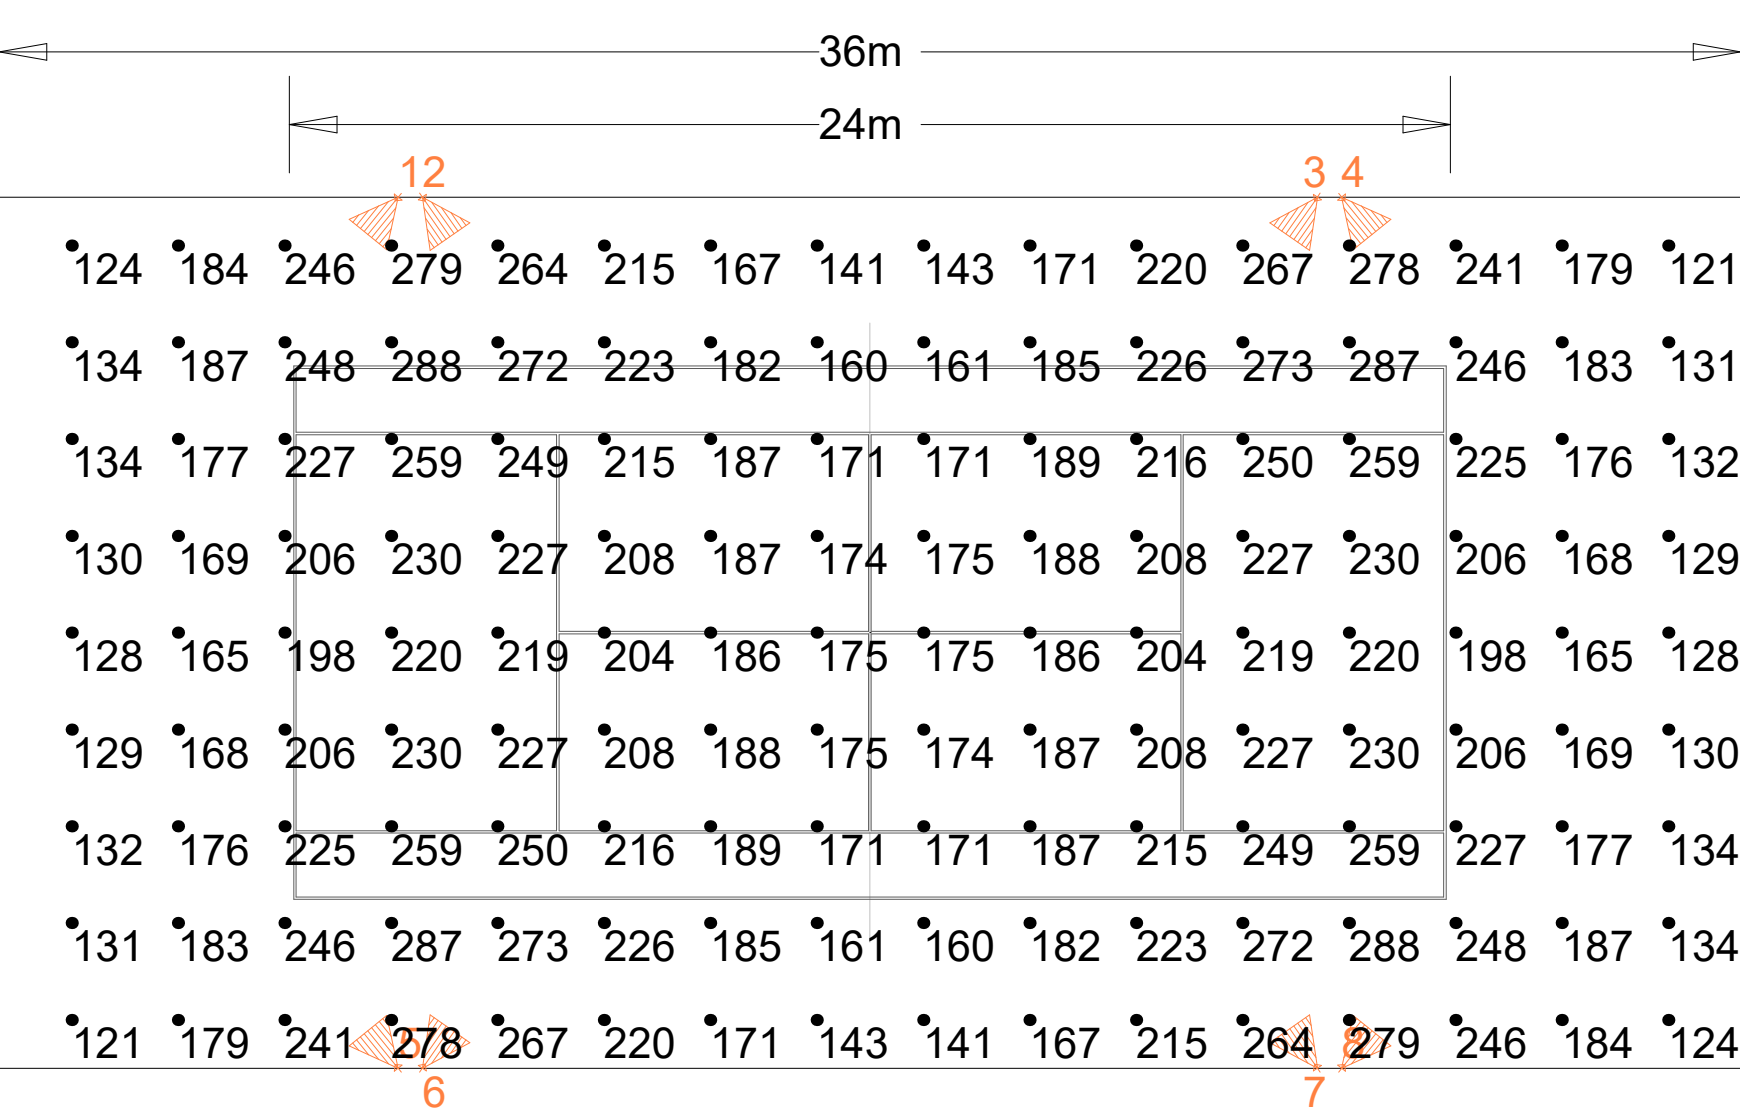

NOTE:
Actual results achieved may vary from predicted values due to normal deviation in luminaire installation, electrical supply, equipment tolerances, obstructions including poles, brackets and mounting arms, reflectances etc.

This design is for general guidance only & its use is subject to conditions (available on request).

Based On
Lumen Output at 20000 Hours,
Spot Lamp Replacement,
Normal Environment,
Annual Cleaning,
Ground is Level.

VeeLite		
Project: Standard Tennis Court Class 3 200 Lux 0.6 Uniformity		
Client: Veelite		
Project No: VL-STC	Drawing No: VL-STC-CL3	Drawn By: GK
Date: 28/09/2023	Scale: As shown	REV NO: A
Single Tennis Court 200lux 8m.AGI		